



ELECTRICAL SYMBOL LEGEND

- ⊖ DUPLEX RECEPTACLE OUTLET.
- ⊖ QUADRUPEX RECEPTACLE OUTLET.
- ▽ TELEPHONE OUTLET.
- ▽ DATA LINE.

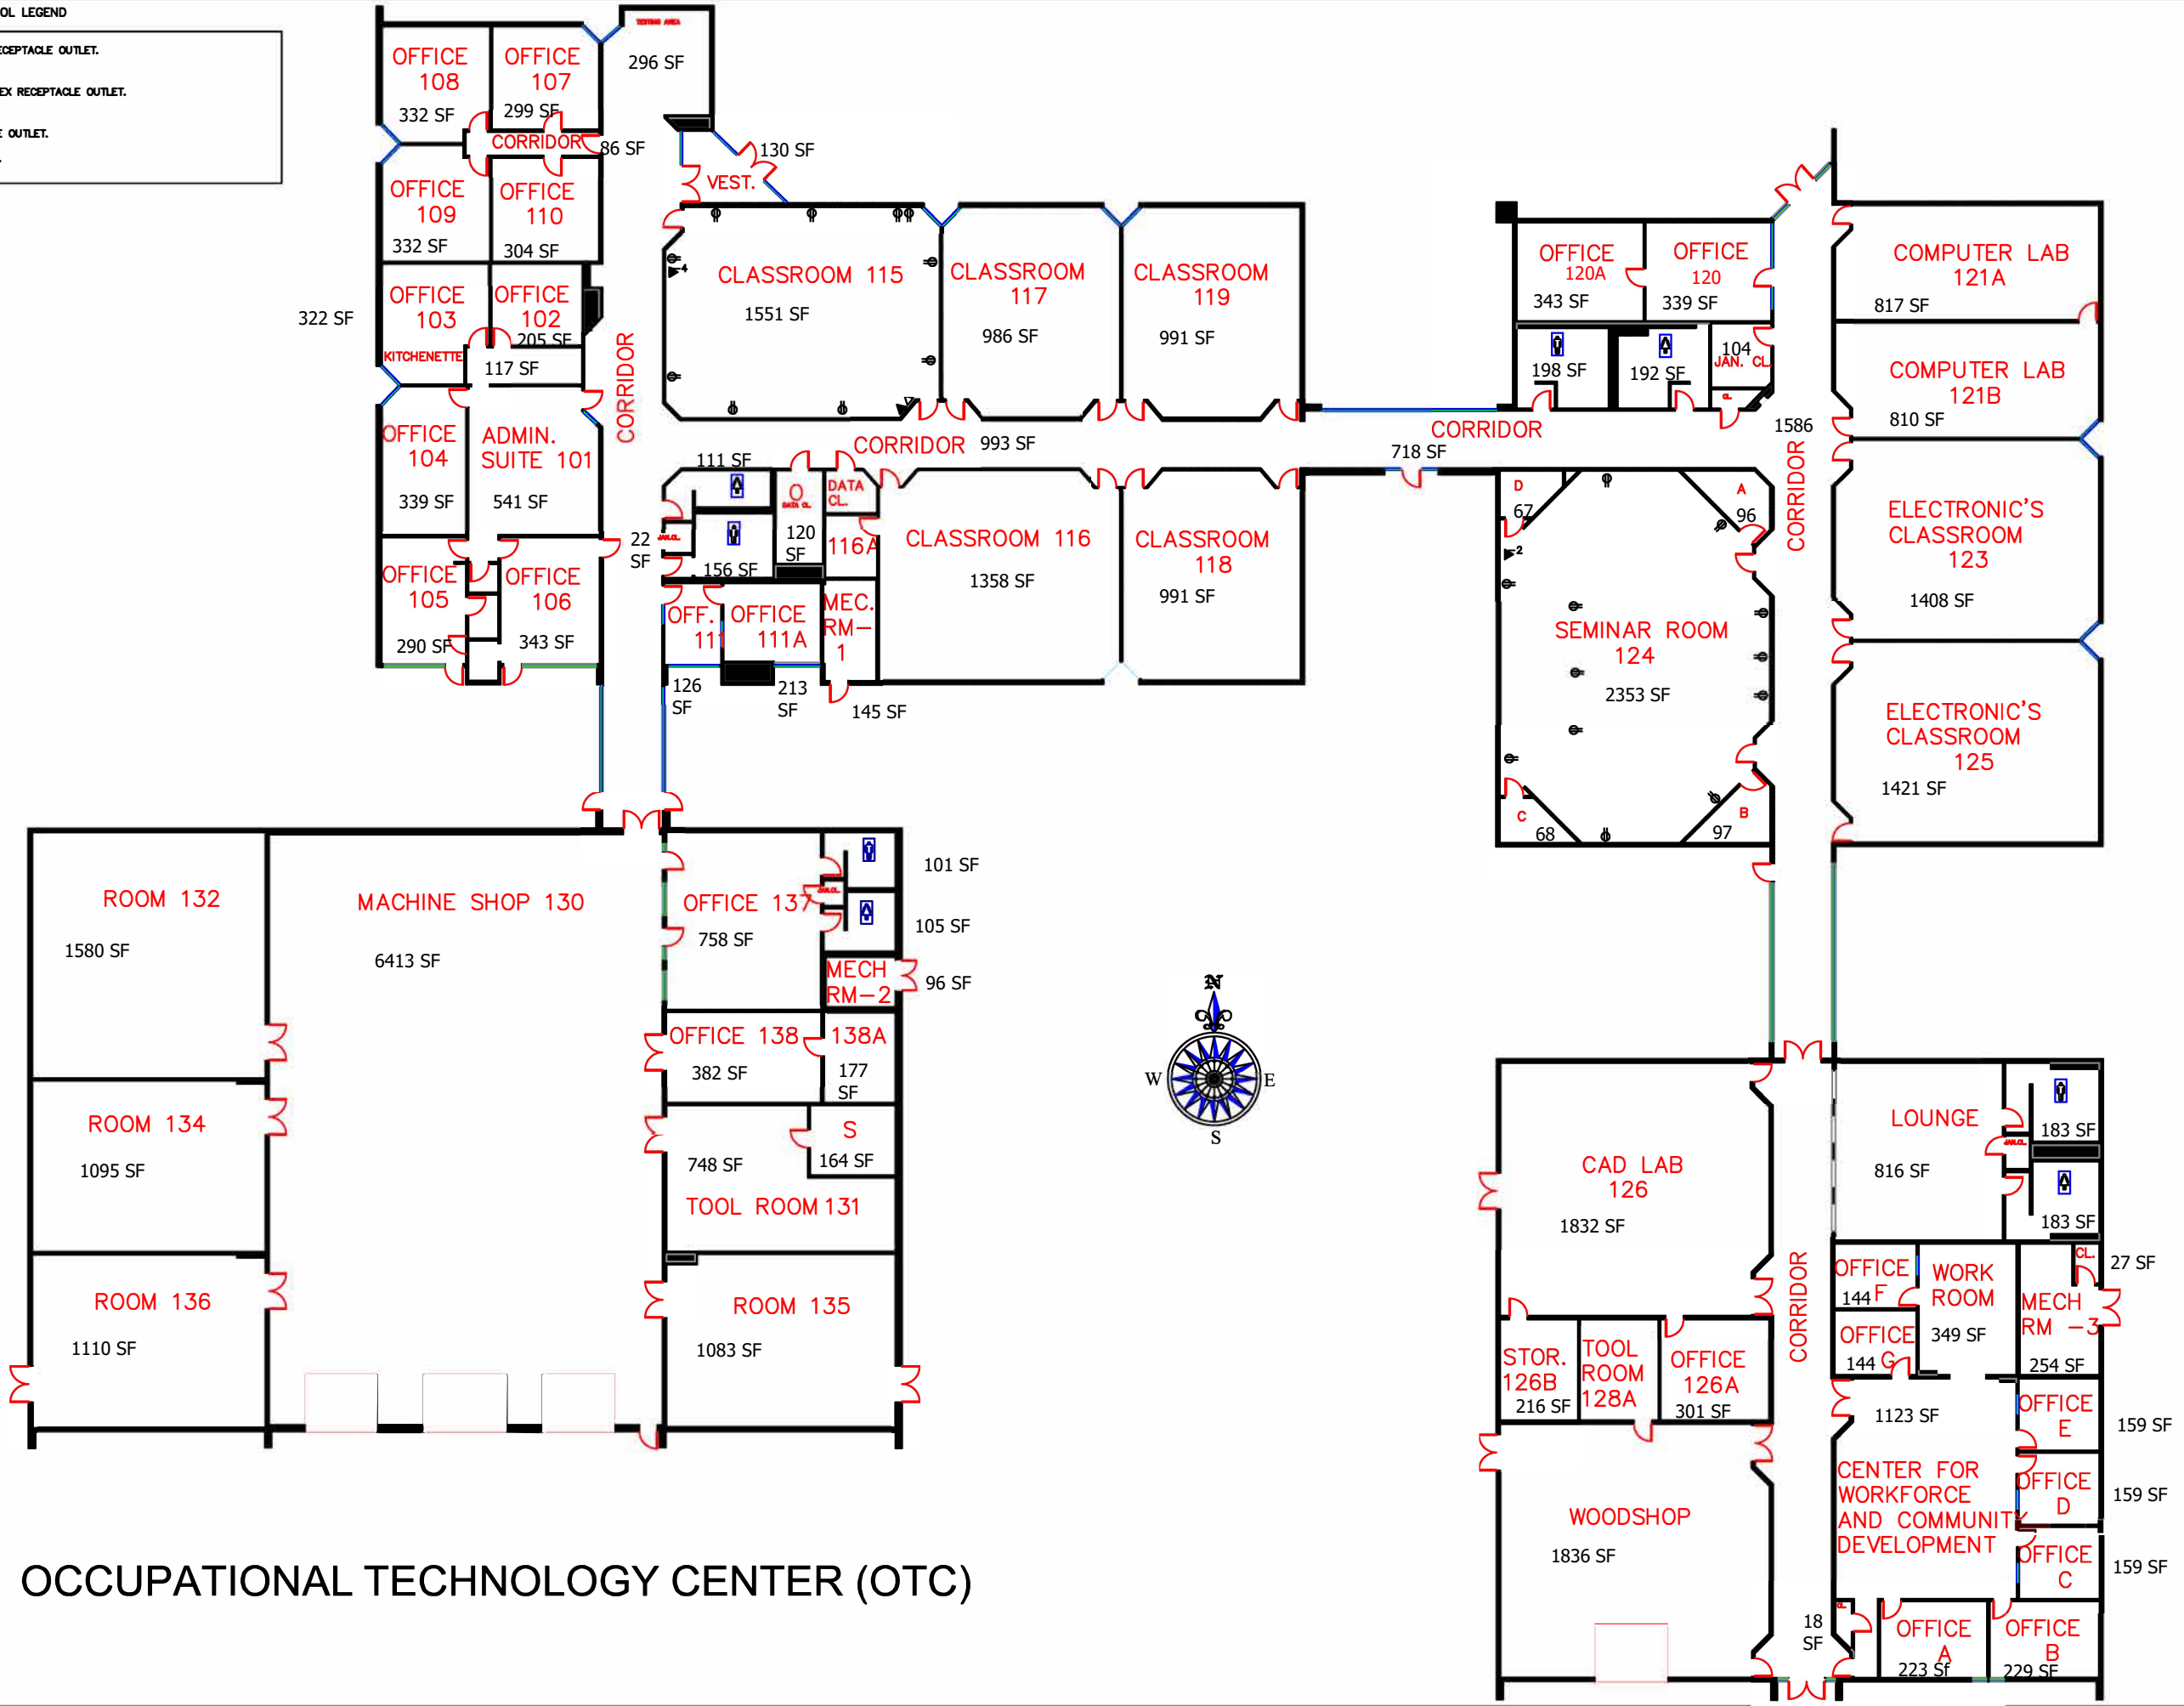

OCCUPATIONAL TECHNOLOGY CENTER (OTC)

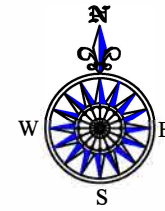

DATE
6/07/05

DRAWN BY:
CHAPMAN / MOFFETT

SCALE:
NTS

OTC
FLOOR PLAN

FILENAME:
Occupational
Technology
Center.dwg



SHEET
1-1